


H.V.AC.	Architecture
Water Supply	Construction
Drainage	A.C.(Electrics)
Automatic	D.C.(Electrics)

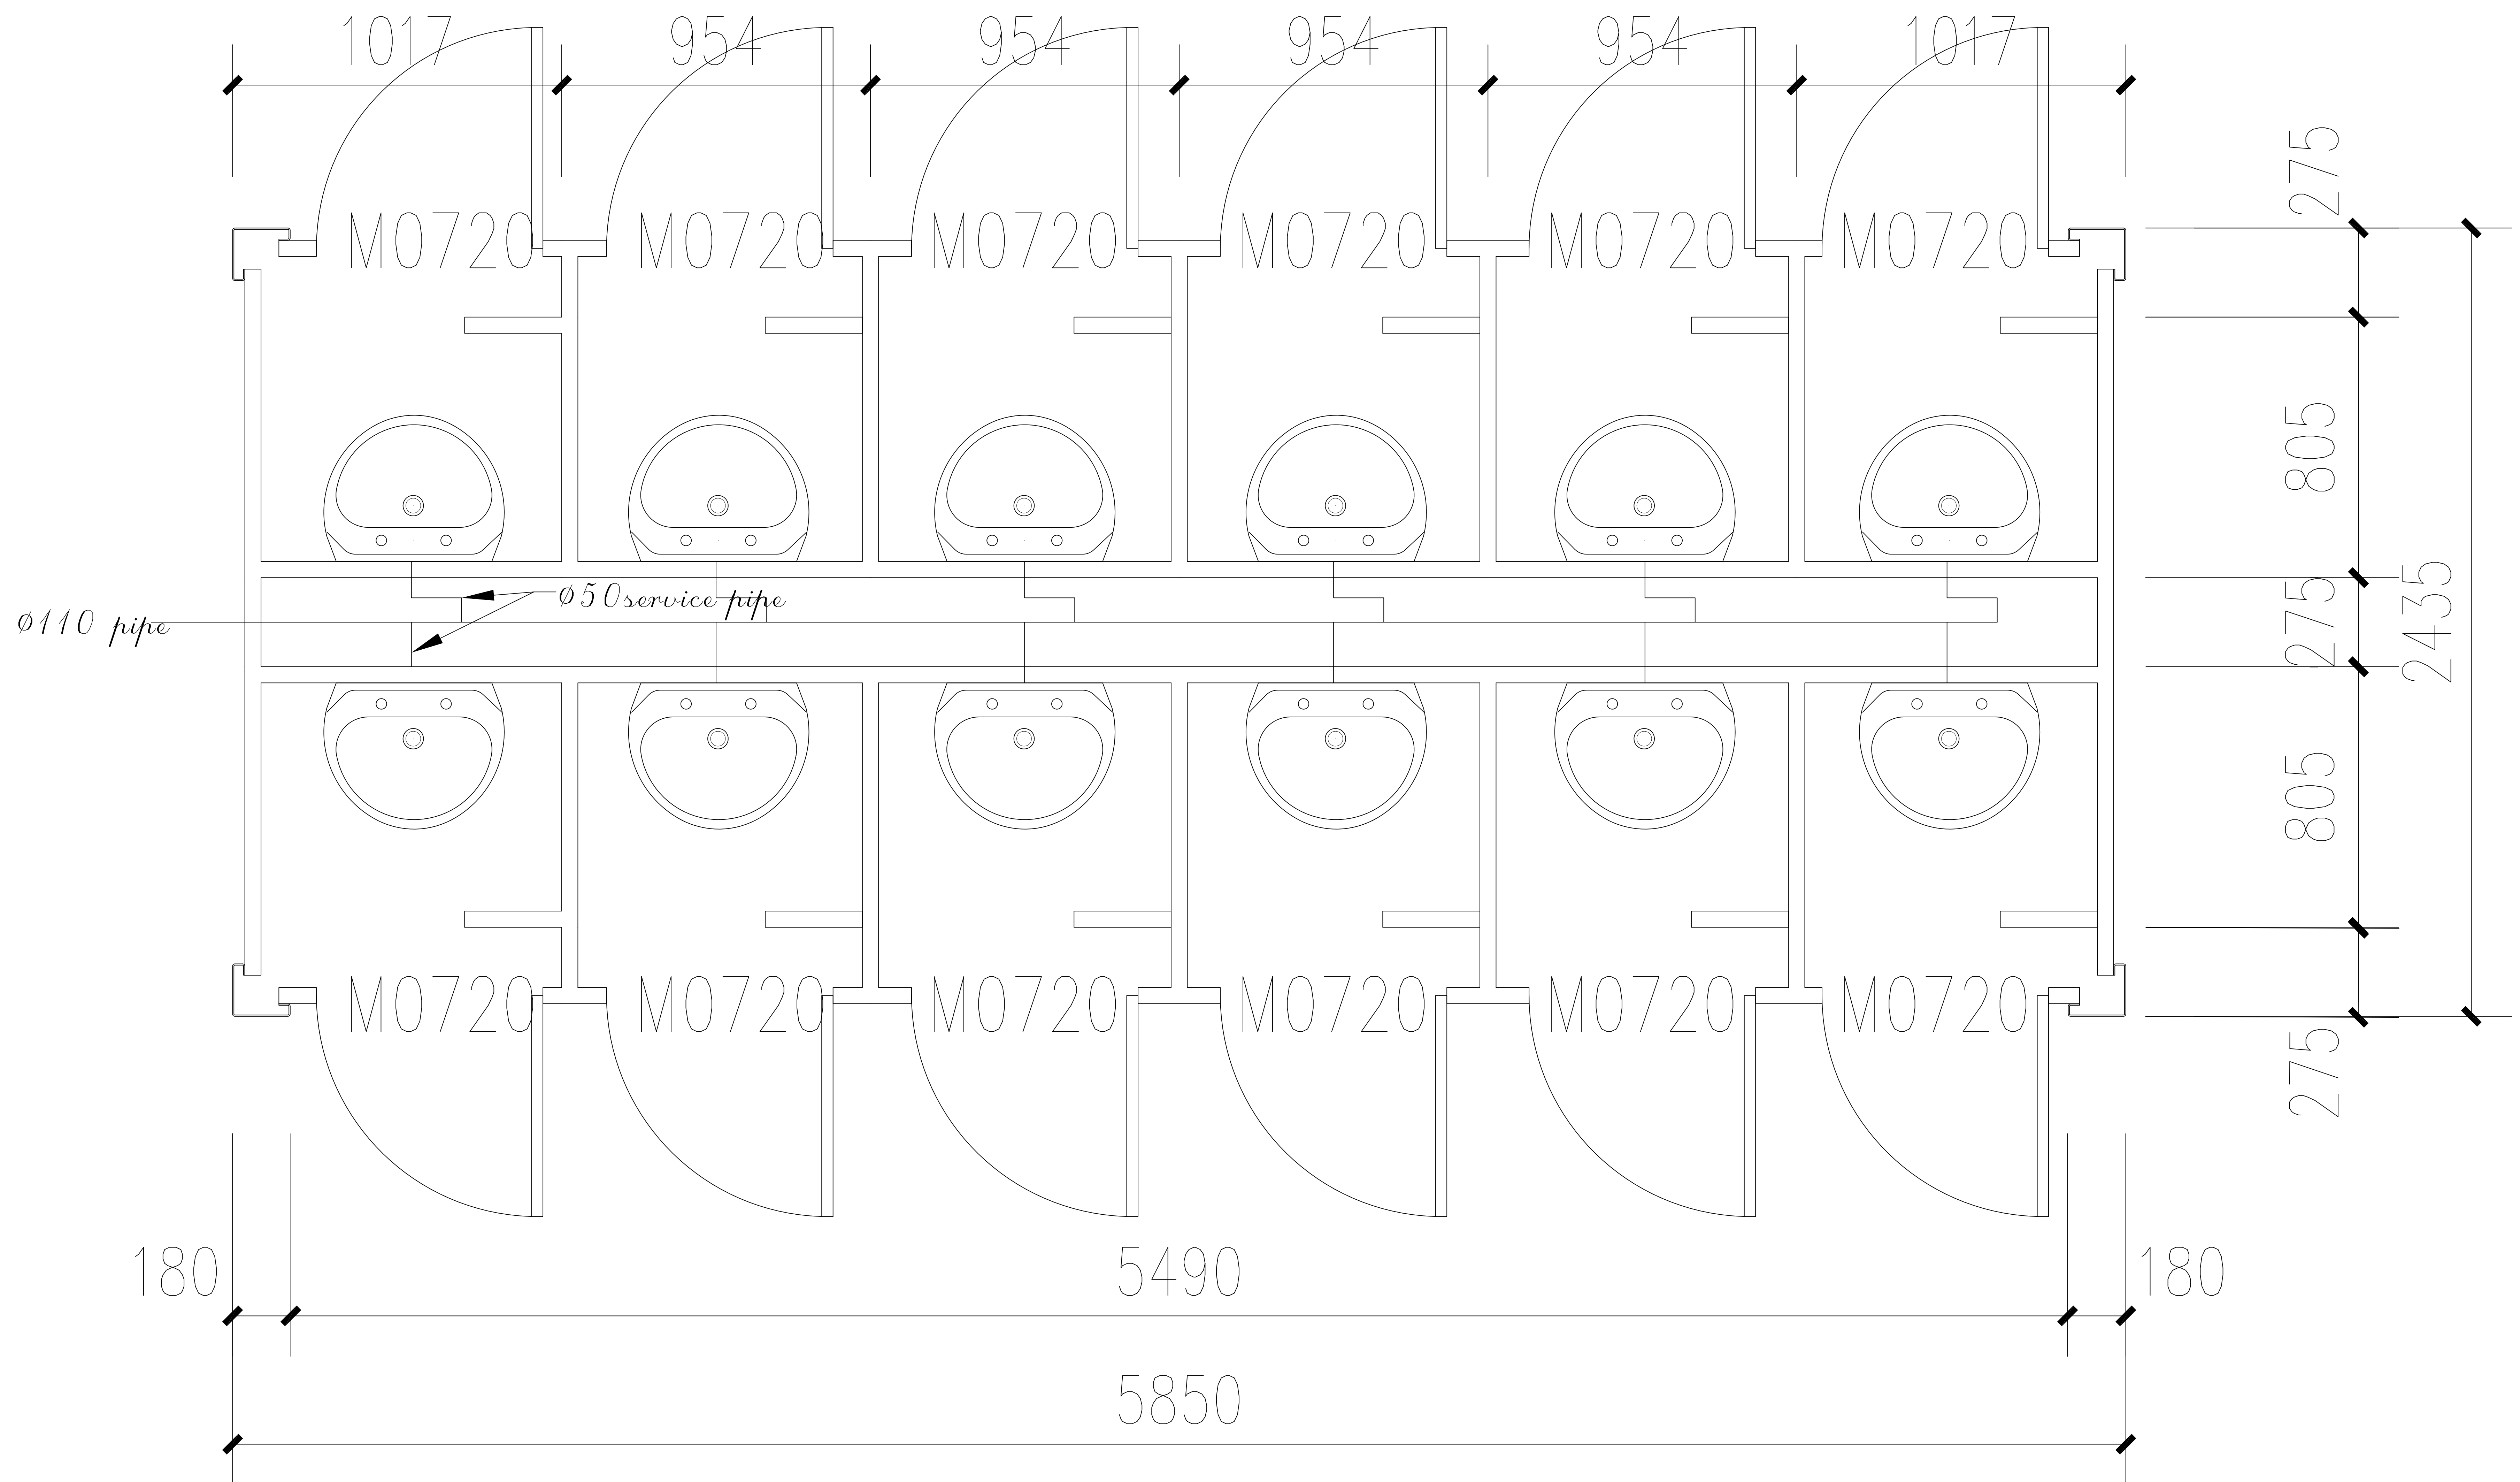

## Floor plan

		<b>KEDA LIGHT STEEL HOUSING SYSTEMS CO.,LTD.</b>			
Contact		Approve		Project	
Tel:		Auditing		Title	2.435m×5.85m×2.9m
		Design		Job No.	
		Check		Drawing No.	
				Date	